



BAMMEL ARCHITECTS
A PROFESSIONAL CORPORATION

6264 WEST QUAKER STREET
ORCHARD PARK, NY 14127
phone (716) 662-2482
fax (716) 662-2487

CONSULTANTS:

Copyright 2020 Bammel Architects PC, all rights reserved. No part of this drawing may be reproduced or copied in any form by any means without the written permission of the architect.
Any unauthorized alteration or addition to this drawing/document is a violation of section 7307 of the New York State education law, article 147-architecture.

SEAL:

ADDITION FOR :

O'NEILL'S STADIUM INN

3864 ABBOTT ROAD
ORCHARD PARK, NY 14127


ISSUE

ISSUE DATE:	08/26/2020
FILE NAME:	8.12.20_takeout_addition_meps
PROJECT NUMBER:	20.27
SCALE:	AS NOTED
DRAWN BY:	JMM
CHECKED BY:	ALL

SHEET TITLE:
MECHANICAL PLAN

DRAWING NO:

M-1

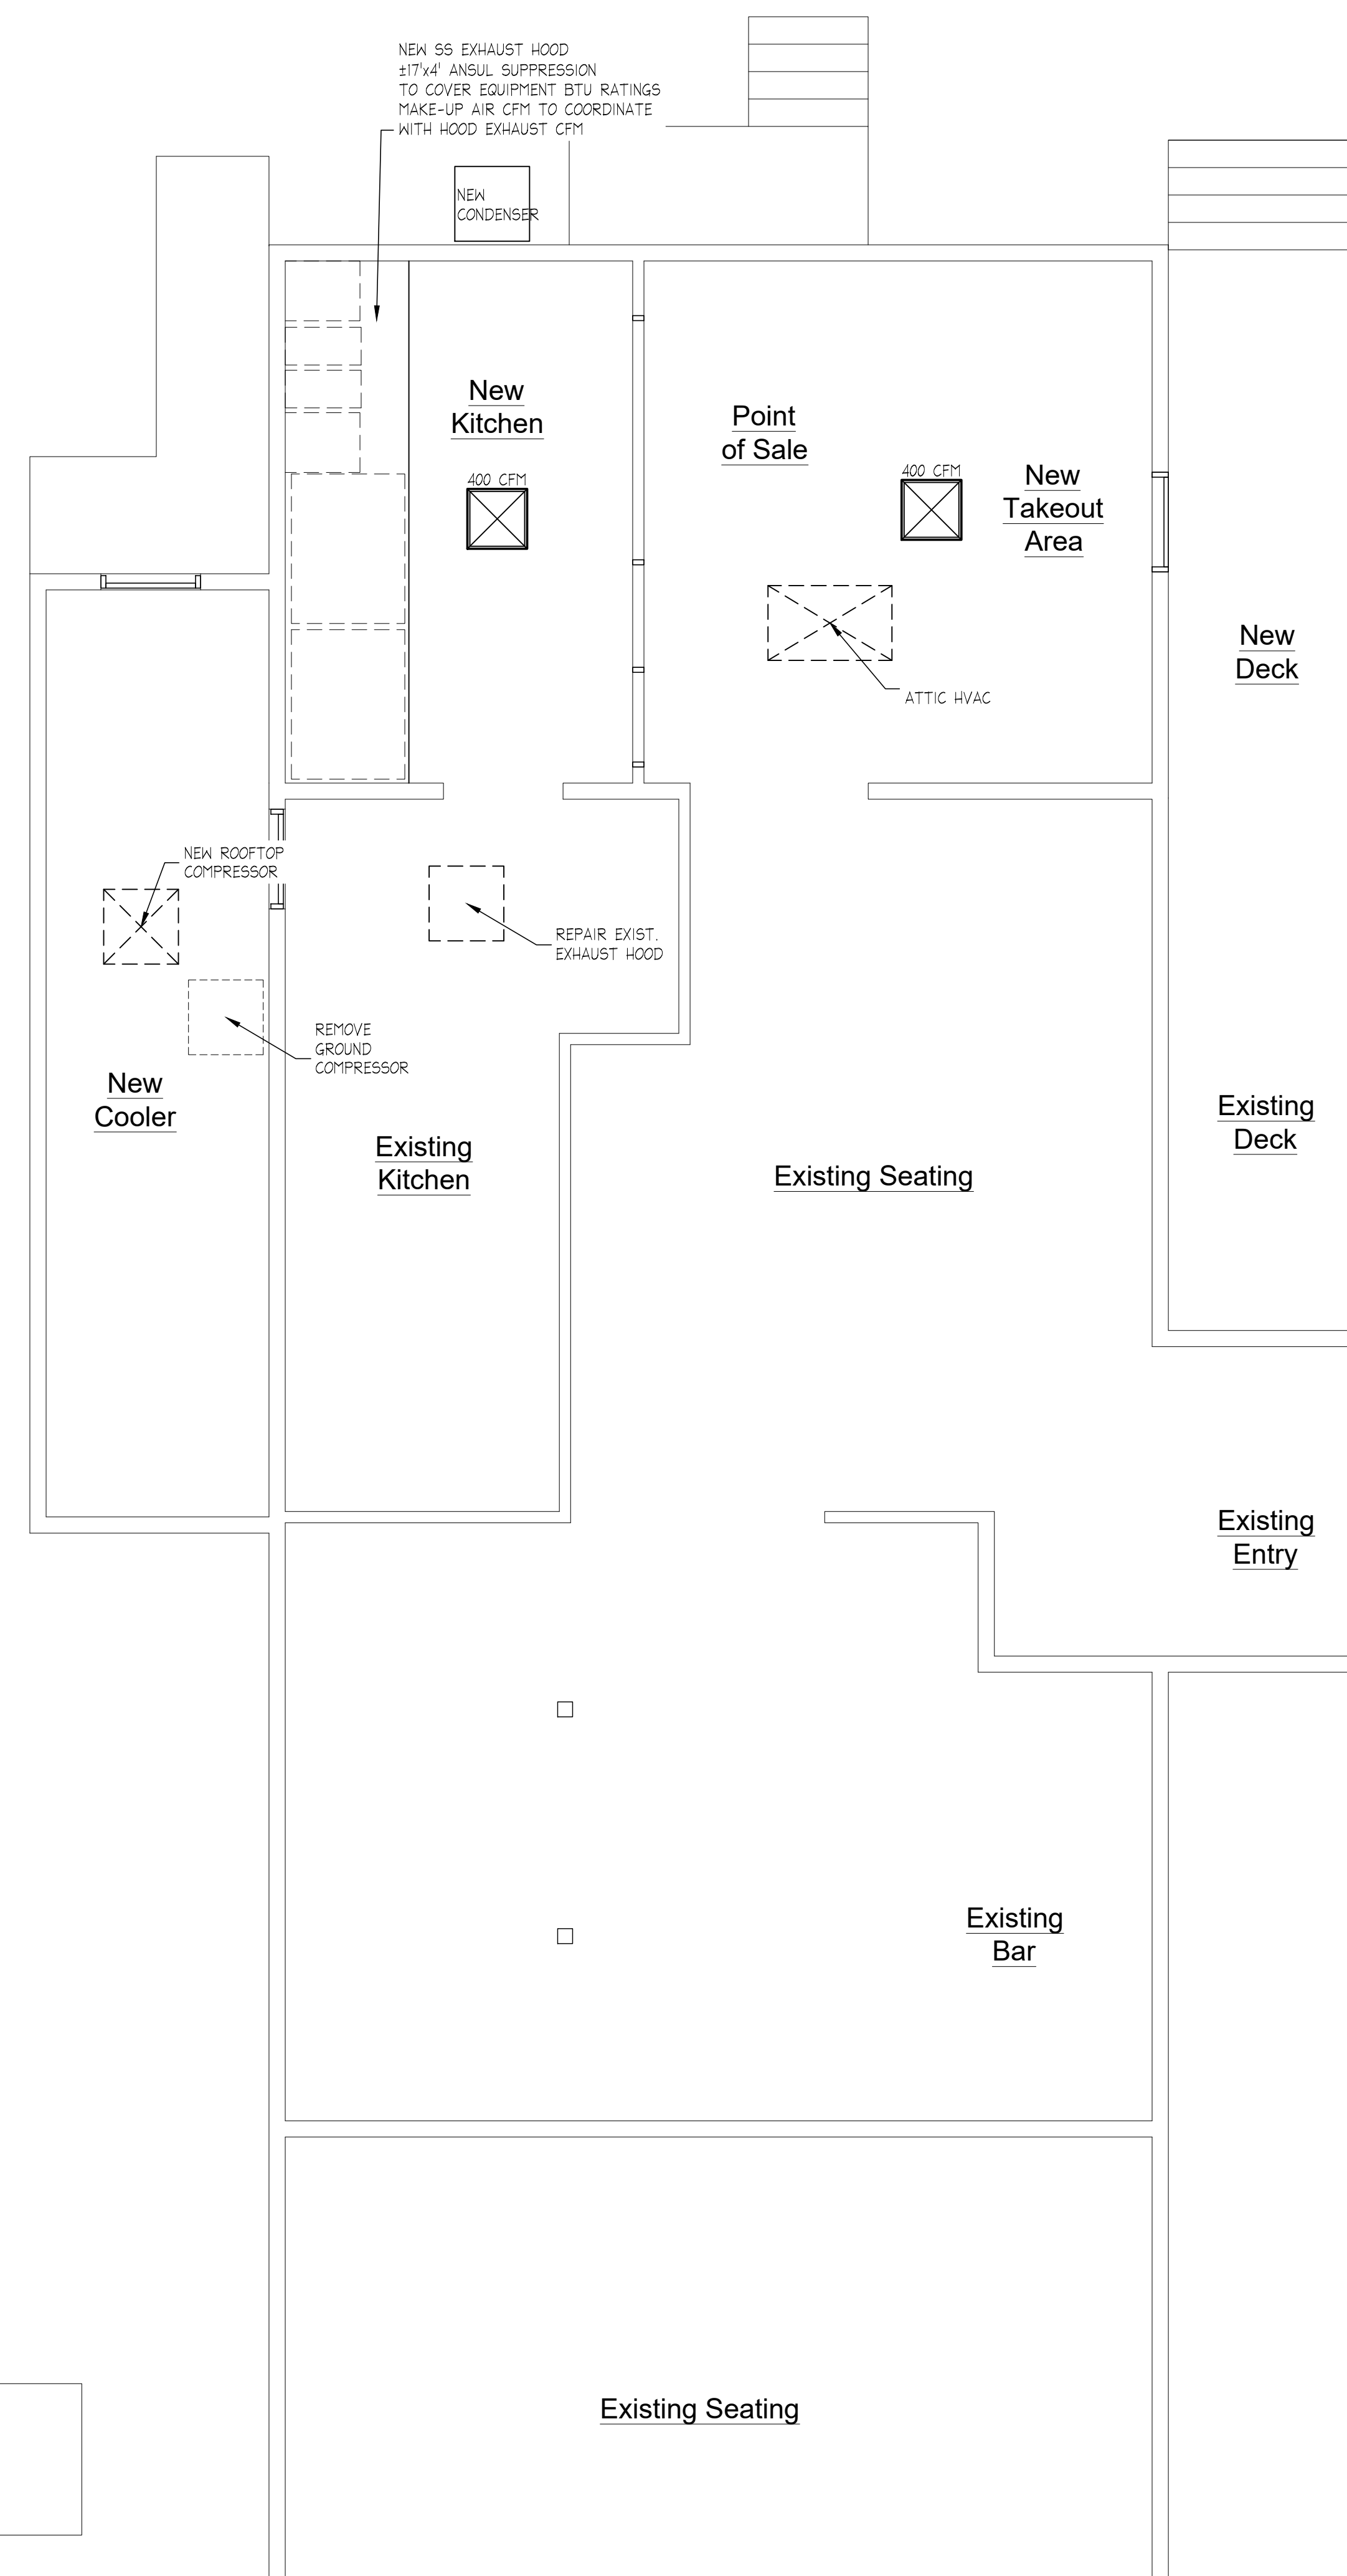

1 MECHANICAL PLAN
1/4" = 1'-0"

